

DEMOLITION NOTES

1. SEE ENGINEERING PLANS FOR DEMOLITION OF UTILITY FEATURES.
2. PROVIDE TREE PROTECTION FENCING AS NOTED AND LOCATED ON PLAN. TREE PROTECTION SHOULD BE LOCATED AROUND THE DRAP LINE, 1' TP.
3. ALL TREES WITH DEMOLITION WITHIN THE PROTECTIVE FENCING (min. of 10') SHALL BE BARICADED PRIOR TO DEMOLITION. THESE BARICADES SHALL BE PLACED AT THE DRAP LINE UNLESS OTHERWISE INSTRUCTED BY THE OWNER'S REPRESENTATIVE.
4. MATERIAL TO BE DEMOLISHED IN THE PROTECTIVE AREA SHALL BE KEPT OUT OF THE BARICADE OR MARKED ON THE MATERIAL ITSELF. TREES OUTSIDE THE CONSTRUCTION AREA THAT HAVE DEMOLITION IN THEIR PROTECTIVE RADI SHALL BE BARICADED AS WELL.
5. BARICADES SHALL BE INSPECTED BY THE OWNERS REPRESENTATIVE BEFORE DEMOLITION STARTS.

6. ALL DEMOLITION INSIDE OF THE BARBOCAGES SHALL BE BY HAND TOOLS. LARGER EQUIPMENT MAY BE USED AFTER NOTIFICATION AND APPROVAL BY THE OWNERS REPRESENTATIVE.
7. NO BELOW GROUND UTILITIES SHALL BE REMOVED FROM THE PROTECTIVE RADIOL OF EXISTING TREES, ABANDON IN PLACE. DO NOT REMOVE CLEAN-OUTS IN THE BARBOCAGED AREAS.
8. STUMPS FOR TREES TO BE REMOVED SHALL BE TAKEN OUT IN THE FOLLOWING MANNER: MAKE PRUNES ON FOUR SIDES OF THE STUMP 5 FT. FROM STUMP BEFORE PULLING STUMP TO PREVENT EXCESSIVE DAMAGE TO ROOTS OF THE TREES TO REMAIN. ROOT PRUNING LOCATIONS SHALL BE APPROVED BY THE OWNERS REPRESENTATIVE IN THE FIELD. THIS NOTE APPLIES ONLY TO TREES TO BE REMOVED FROM WITHIN THE CLOSED AREA ON PLAN OF A TREE TO REMAIN. ROOT PRUNES AS SHOWN AS POSSIBLE TO THE TRUNK OF THE TREE TO BE REMOVED. THERE ARE A TOTAL OF 9 STUMPS ON THE PLANS.

9. ALL ENTRY IN THE BARRICADES MUST BE APPROVED BY OWNER'S REPRESENTATIVE.


10. NO BELOW GROUND UTILITIES SHALL BE INSTALLED WITHIN 10 FT OF EXISTING TREES. THIS APPLIES TO WATER, SEWER, IRRIGATION, LIGHTING PLANS, ETC.

DEMOLITION LEGEND

- | | |
|---|--|
|  | Buildings to remain |
|  | Building and sidewalk to be removed. Contractor to verify extent of demolition shown |
|  | Existing trees to be removed with root mass-Sidewalk |
|  | Tree Protection not to be removed until construction within line of protection must begin. |
|  | Unit of work & Construction Fence w/ Screen |
|  | Existing fence to be removed and relocated. |

DEMOLITION KEY

- A. Remove all above grade and below grade construction. Included but NOT LIMITED TO: Buildings, concrete slabs and paving; retaining walls, footings and curbs; benches, drinking fountains and other structures; utility structures; and other structures; and other site furnishings, asphalt and gravel paving, chain link fencing.
- B. Remove fencing including foundation and turn materials over to Owner, if requested. Otherwise dispose of site.
- C. Verify with Owner existing items to be removed and turned over to Owner.
- D. Contractor to control site erosion wash-out at the limit of work line and install all site drainage structures. Refer to Civil or Erosion Control Site Plan.
- E. Concrete wash-out site for all wash-out of ready mix trucks and concrete loads shall be in a disquescent limit placed a minimum of 20 feet from all tree roots zones. The pit must be removed from the site before project closure. The pit location must be approved by the Architect and Owner's Representative.
- F. Construction fence to follow limit of work line where existing fence not present. See Specifications.
- G. Saw cut existing paving.

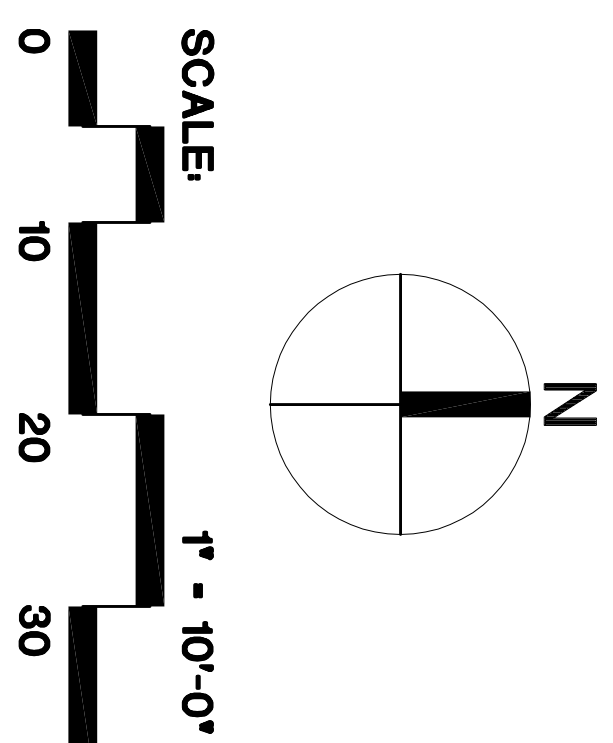

	ADDENDUM ADDED	1/25/08
NO.	REVISIONS/SUBMISSIONS	DATE



TORRE DESIGN
CONSORTIUM, LTD.
 A PROFESSIONAL ARCHITECTURAL CORPORATION

 ARCHITECTURE LANDSCAPE ARCHITECTURE
 PLANNING INTERIOR DESIGN

 MAGNOLIA ST., NEW ORLEANS, LOUISIANA 70115-1795 (504) 581-2012 FAX (504) 581-2088

PROJECT TITLE

MEMPHIS ZOO AND
AQUARIUM IMPROVEMENTS
TETON TREK

		DRAWING TITLE DEMOLITION PLAN A	
DESIGNED	PROJECT NO.	28005	
DRAWN	SCALE	1" = 10'-0"	
CHECKED	DRAWING NO.		
REVIEWED			
DATE			
9/07			
DP01 8 OF 240			